


EXHIBIT A

Anne Arundel Medical Center

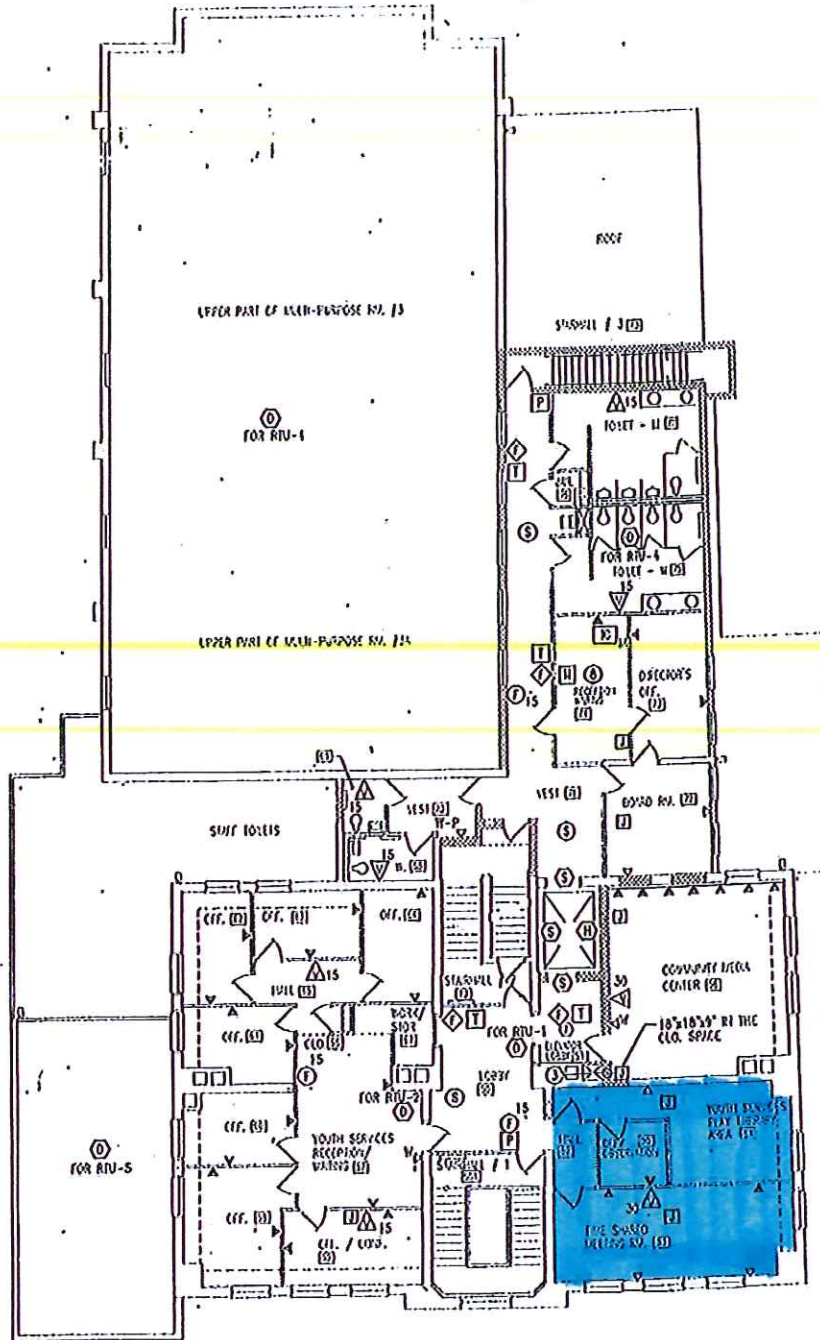

SECOND FLOOR PLAN
NOT TO SCALE

FLOOR PLAN ACQUIRED
FROM THE PLAN SHEET ENTITLED:

STANTON COMMUNITY CENTER ANAPOLIS, MARYLAND	
ELECTRICAL LIGHTING	
FRY & WELCH ASSOCIATES, P.O. 1652 GEORGE AVENUE, NW, WASHINGTON, D.C., 20037 TEL (202) 233-0300	
FRY & WELCH ASSOCIATES, INC. 1652 GEORGE AVENUE, NW WASHINGTON, D.C. 20037 TEL (202) 233-0300	PROJECT NO. DATE: 11/04/14 14:15:57 SCALE: AS SHOWN SHEET NO. E-6 DATE: 11/04/14