


EXHIBIT A

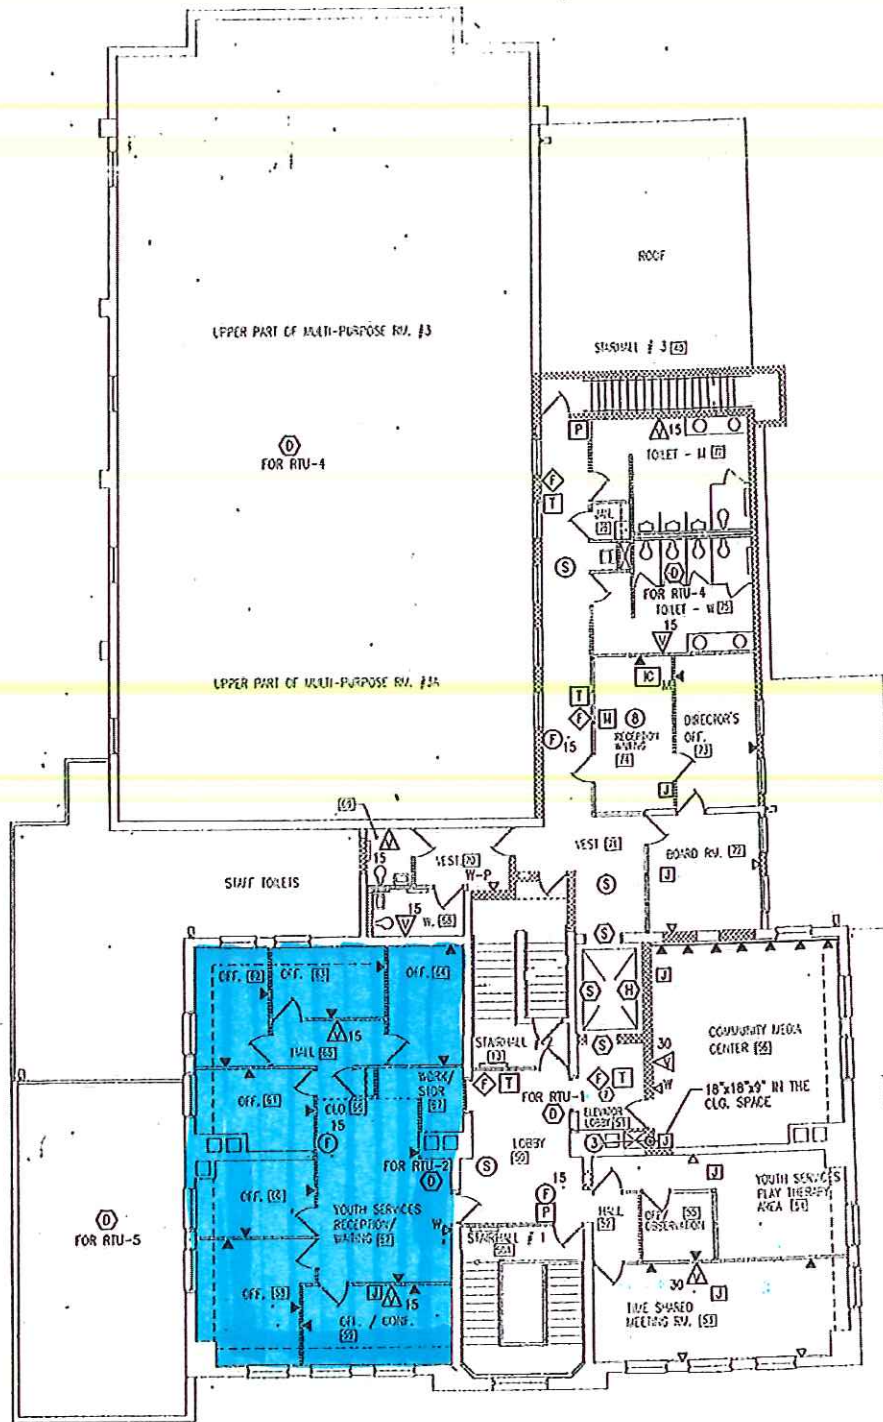

SECOND FLOOR PLAN
NOT TO SCALE

FLOOR PLAN ACQUIRED
FROM THE PLAN SHEET ENTITLED:

STANTON COMMUNITY CENTER
ANNAPOLIS, MARYLAND

ELECTRICAL LIGHTING

FRY & WELCH ASSOCIATES, P.C.
7650 GEORGIA AVENUE, N.W., WASHINGTON, D.C., 20012
TEL (202) 829-0700

FWA ASSOCIATES, INC.
1000 YORK ROAD
FREDERICK, MARYLAND 21733
PHONE (410) 541-3155

PROJECT NO.
DATE: NOV 28, 1997
SCALE: AS SHOWN
DWG. NO. **E-6**
SHEET 48 OF 54