


EXHIBIT

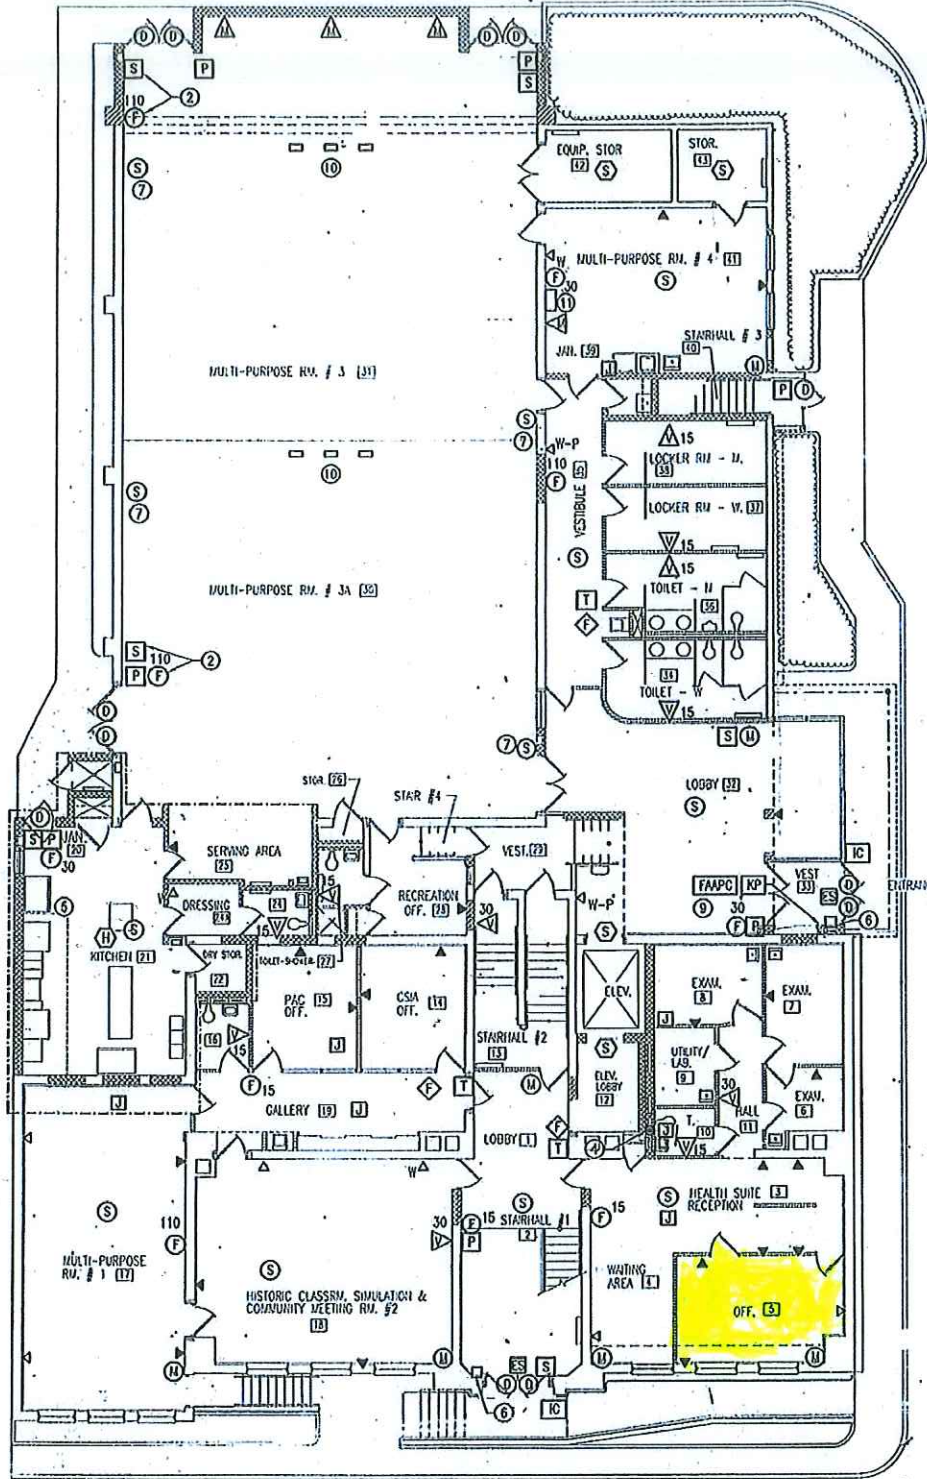

FIRST FLOOR PLAN
NOT TO SCALE

FLOOR PLAN ACQUIRED FROM THE PLAN SHEET ENTITLED:

STANTON COMMUNITY CENTER
ANNAPOLIS, MARYLAND

ELECTRICAL LIGHTING

FRY & WELCH ASSOCIATES, P.C.
7600 GEORGIA AVENUE, N.W., WASHINGTON D.C., 20012
TEL: (202) 829-0700

	PROJECT NO.
	DATE: NOV 28, 1997 SCALE: AS SHOWN DWG. NO. E-6 SHEET 28 OF 20