


EXHIBIT A

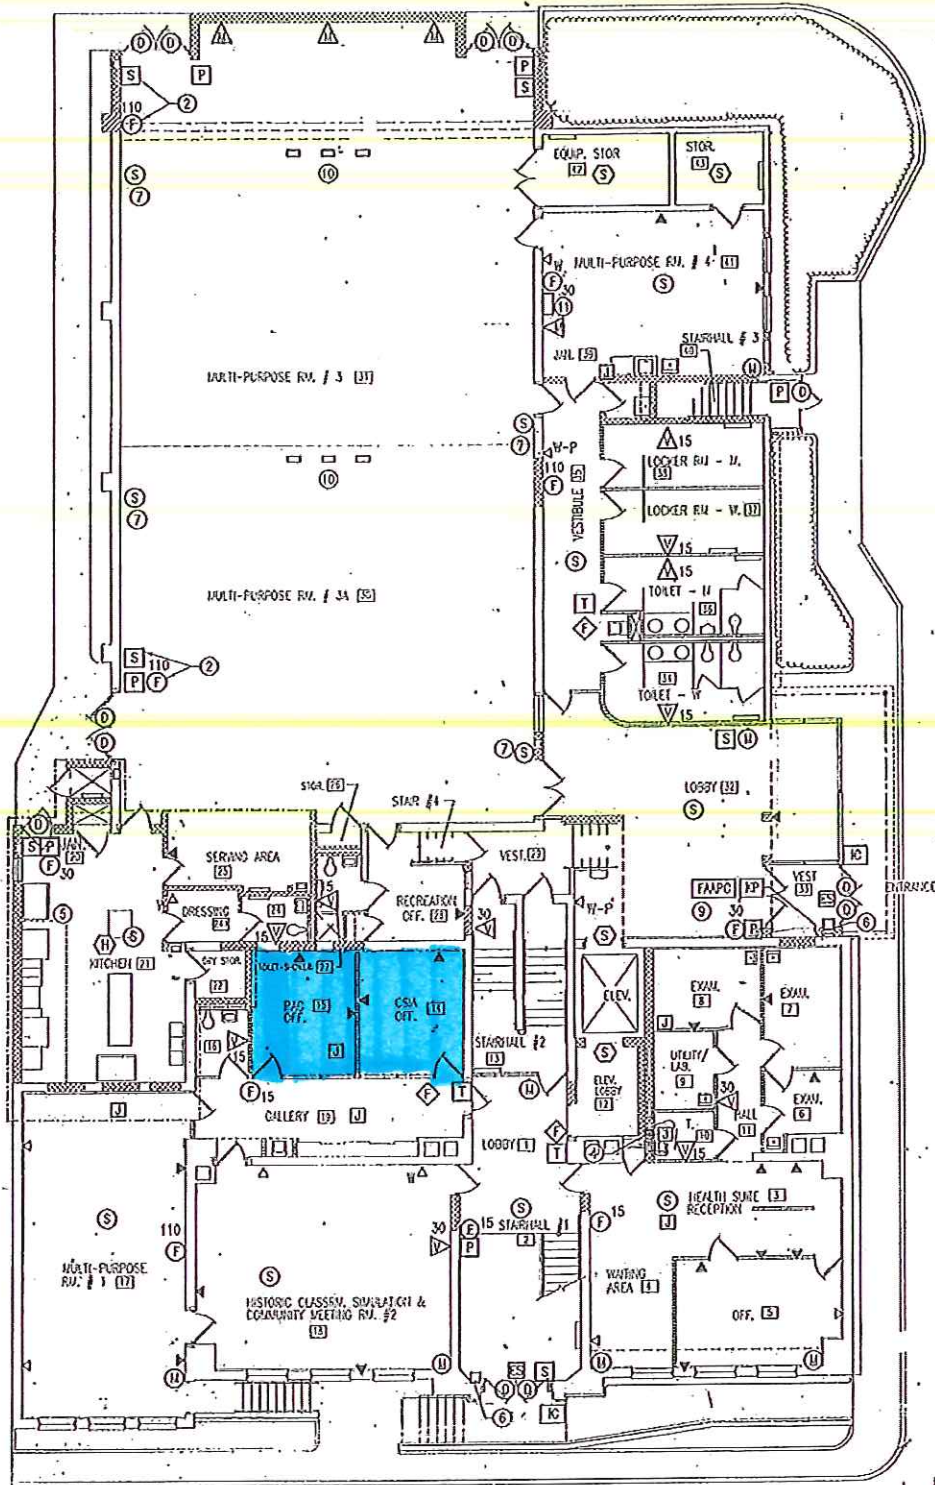

**FIRST FLOOR PLAN
NOT TO SCALE**

FLOOR PLAN ACQUIRED FROM THE PLAN SHEET ENTITLED:

**STANTON COMMUNITY CENTER
ANNAPOLIS, MARYLAND**

ELECTRICAL LIGHTING

FRY & WELCH ASSOCIATES, P.C.
1600 GEORGIA AVENUE, N.W., WASHINGTON D.C., 20012
TEL: (202) 829-0700

FIDHU ASSOCIATES, INC.
2315 YORK ROAD
ANNAPOLIS, MARYLAND 21403
PHONE (410) 241-5133

PROJECT NO.
DATE: NOV 23, 1997
SCALE: AS SHOWN
SHEET NO. **E-6**
SHEET 28 OF 50