


# EXHIBIT A

WeCare

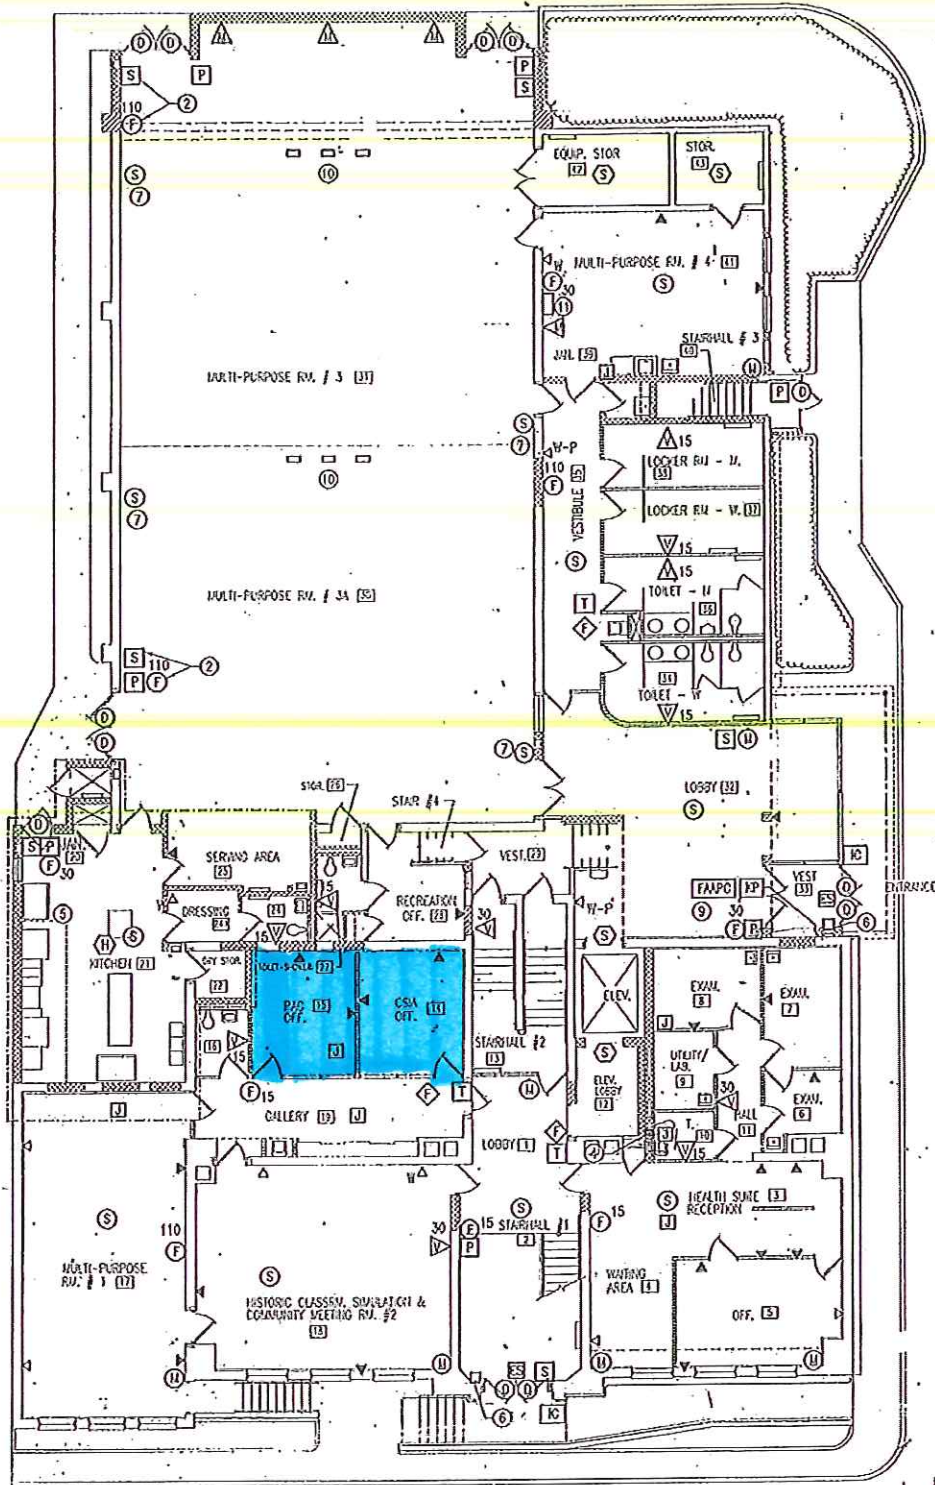

**FIRST FLOOR PLAN  
NOT TO SCALE**

FLOOR PLAN ACQUIRED FROM THE PLAN SHEET ENTITLED:

<b>STANTON COMMUNITY CENTER</b> ANNAPOLIS, MARYLAND	
<b>ELECTRICAL LIGHTING</b>	
FRY & WELCH ASSOCIATES, P.C. 1600 GEORGIA AVENUE, N.W., WASHINGTON D.C., 20012 TEL: (202) 829-0700	
PROJECT NO.	DWG-NOV 23, 1997
SCALE AS SHOWN	NO. 103
<b>FIDHU ASSOCIATES, INC.</b> 2315 YORK ROAD ANNAPOLIS, MARYLAND 21403 PHONE (410) 241-5133	<b>E-6</b> SHEET 28 OF 50