


# EXHIBIT A

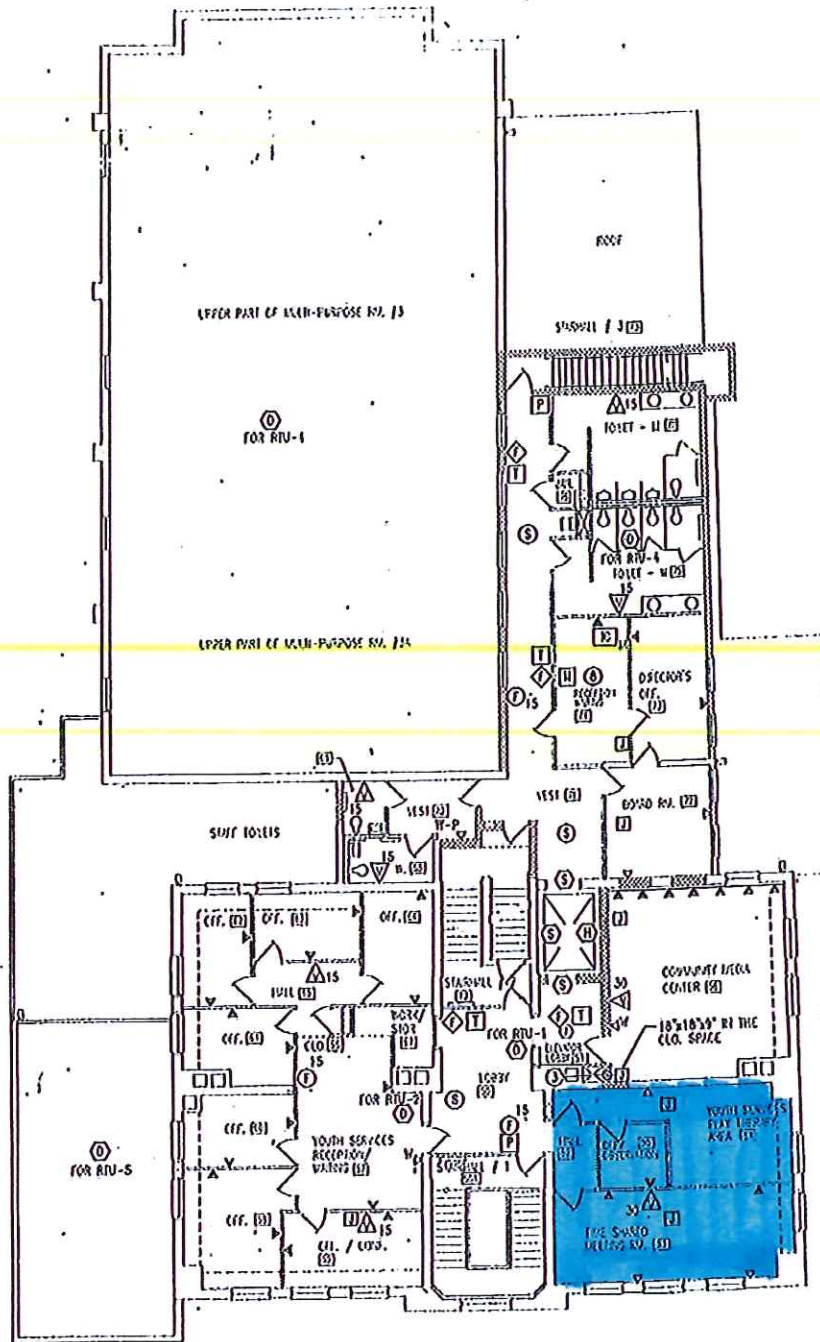

**SECOND FLOOR PLAN**  
NOT TO SCALE

FLOOR PLAN ACQUIRED  
FROM THE PLAN SHEET ENTITLED:

|  |  |
|--|--|
| <b>STANTON COMMUNITY CENTER</b><br>ANAPOLIS, MARYLAND  |  |
| <b>ELECTRICAL LIGHTING</b>   |  |
| FRY & WELCH ASSOCIATES, P.O.<br>1652 GEORGE AVENUE, NW, WASHINGTON, D.C., 20037<br>TEL (202) 233-0300  |  |
|  FRY & WELCH ASSOCIATES, INC.<br>1652 GEORGE AVENUE, NW<br>WASHINGTON, D.C. 20037<br>TEL (202) 233-0300 | PROJECT NO.<br>DATE: 11/04/14 14:15:57<br>SCALE: AS SHOWN<br>SHEET NO.<br><b>E-6</b><br>DATE: 11/04/14 |