


EXHIBIT A

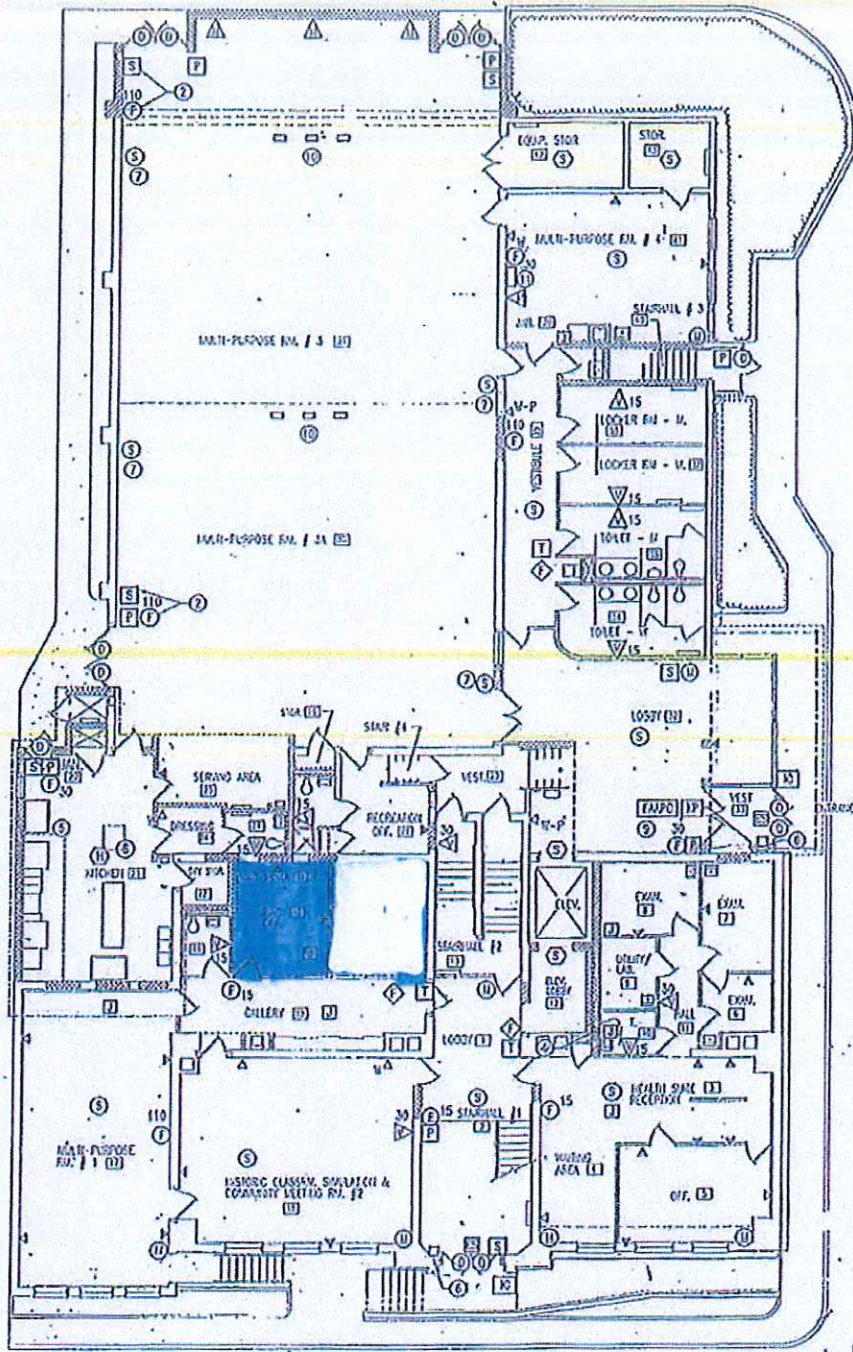

FIRST FLOOR PLAN
NOT TO SCALE

FLOOR PLAN ACQUIRED
FROM THE PLAN SHEET ENTITLED:

STANTON COMMUNITY CENTER ANNAPOLIS, MARYLAND	
ELECTRICAL LIGHTING	
FRY & WELCH ASSOCIATES, P.C. 1609 GEORGIA AVENUE, N.W., WASHINGTON D.C., 20012 TEL: (202) 822-0700	
FRY & WELCH ASSOCIATES, INC. 2115 YORK BLVD. ANNAPOLIS, MARYLAND 21403 PHONE: (410) 211-1310	PROJECT NO. ONE-1100 13 1577 SCALE AS SHOWN REV. NO. E-6 SHEET NO. 11 OF 17